


Electrical R-OPTIONS (ALL MEASUREMENTS A.F.F.)

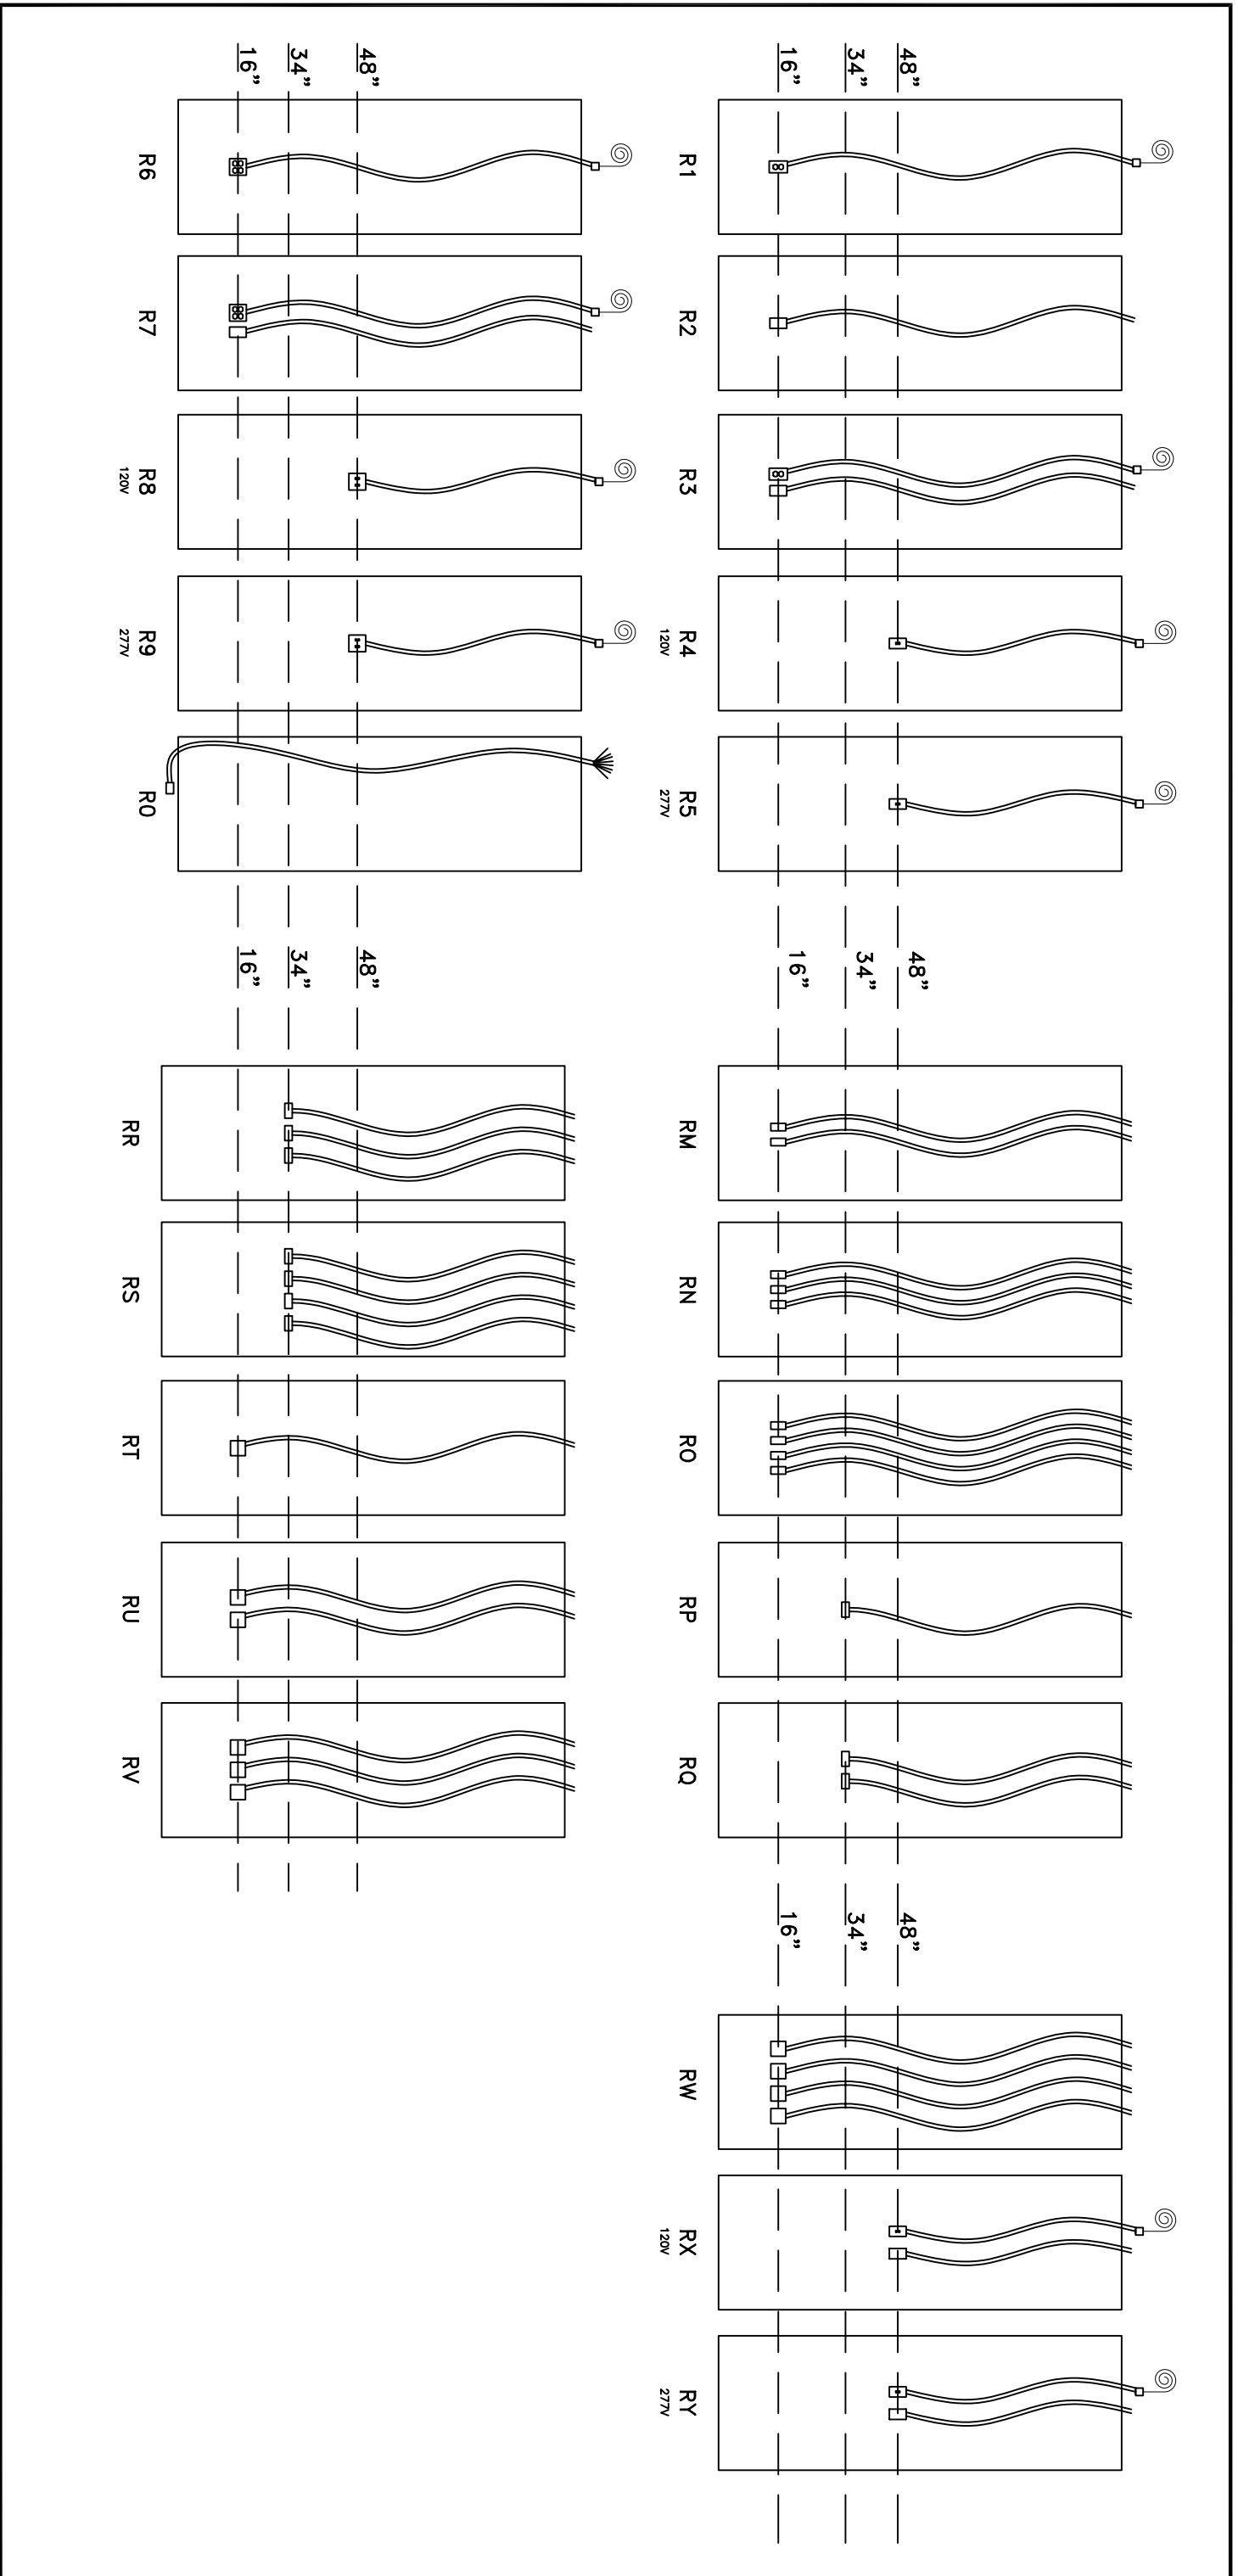

SCA Walls, Inc.
Herman Miller Wall Alliance

LEGEND: FINISHES

	ALUM. FIN.	FIN. FIN. #1
	BRICK FIN. & HT	FIN. FIN. #2
	DOOR	FIN. FIN. #3
	OTHER	FIN. FIN. #4
		GLAZ. FIN. #1
		GLAZ. FIN. #2
		GLAZ. FIN. #3
		GLAZ. FIN. #4

This document contains Proprietary Information and is the sole property of SCA Walls, Inc. Any use thereof and/or reproduction is expressly prohibited without the prior written consent of SCA Walls, Inc.

DRAWN BY: M. Lee	DATE: 8/31/07
CHECKED BY:	DATE:
AWARDED:	PHONE: 800.255.9255
CUSTOMER SIGNATURE:	DATE:


www.scawalls.com

01

ELECTRICAL OPTIONS
R-OPTIONS

SCALE: 1 of 4
DRAWING NO.: SCA-Electrical Options

Electrical S-OPTIONS (ALL MEASUREMENTS A.F.F.)

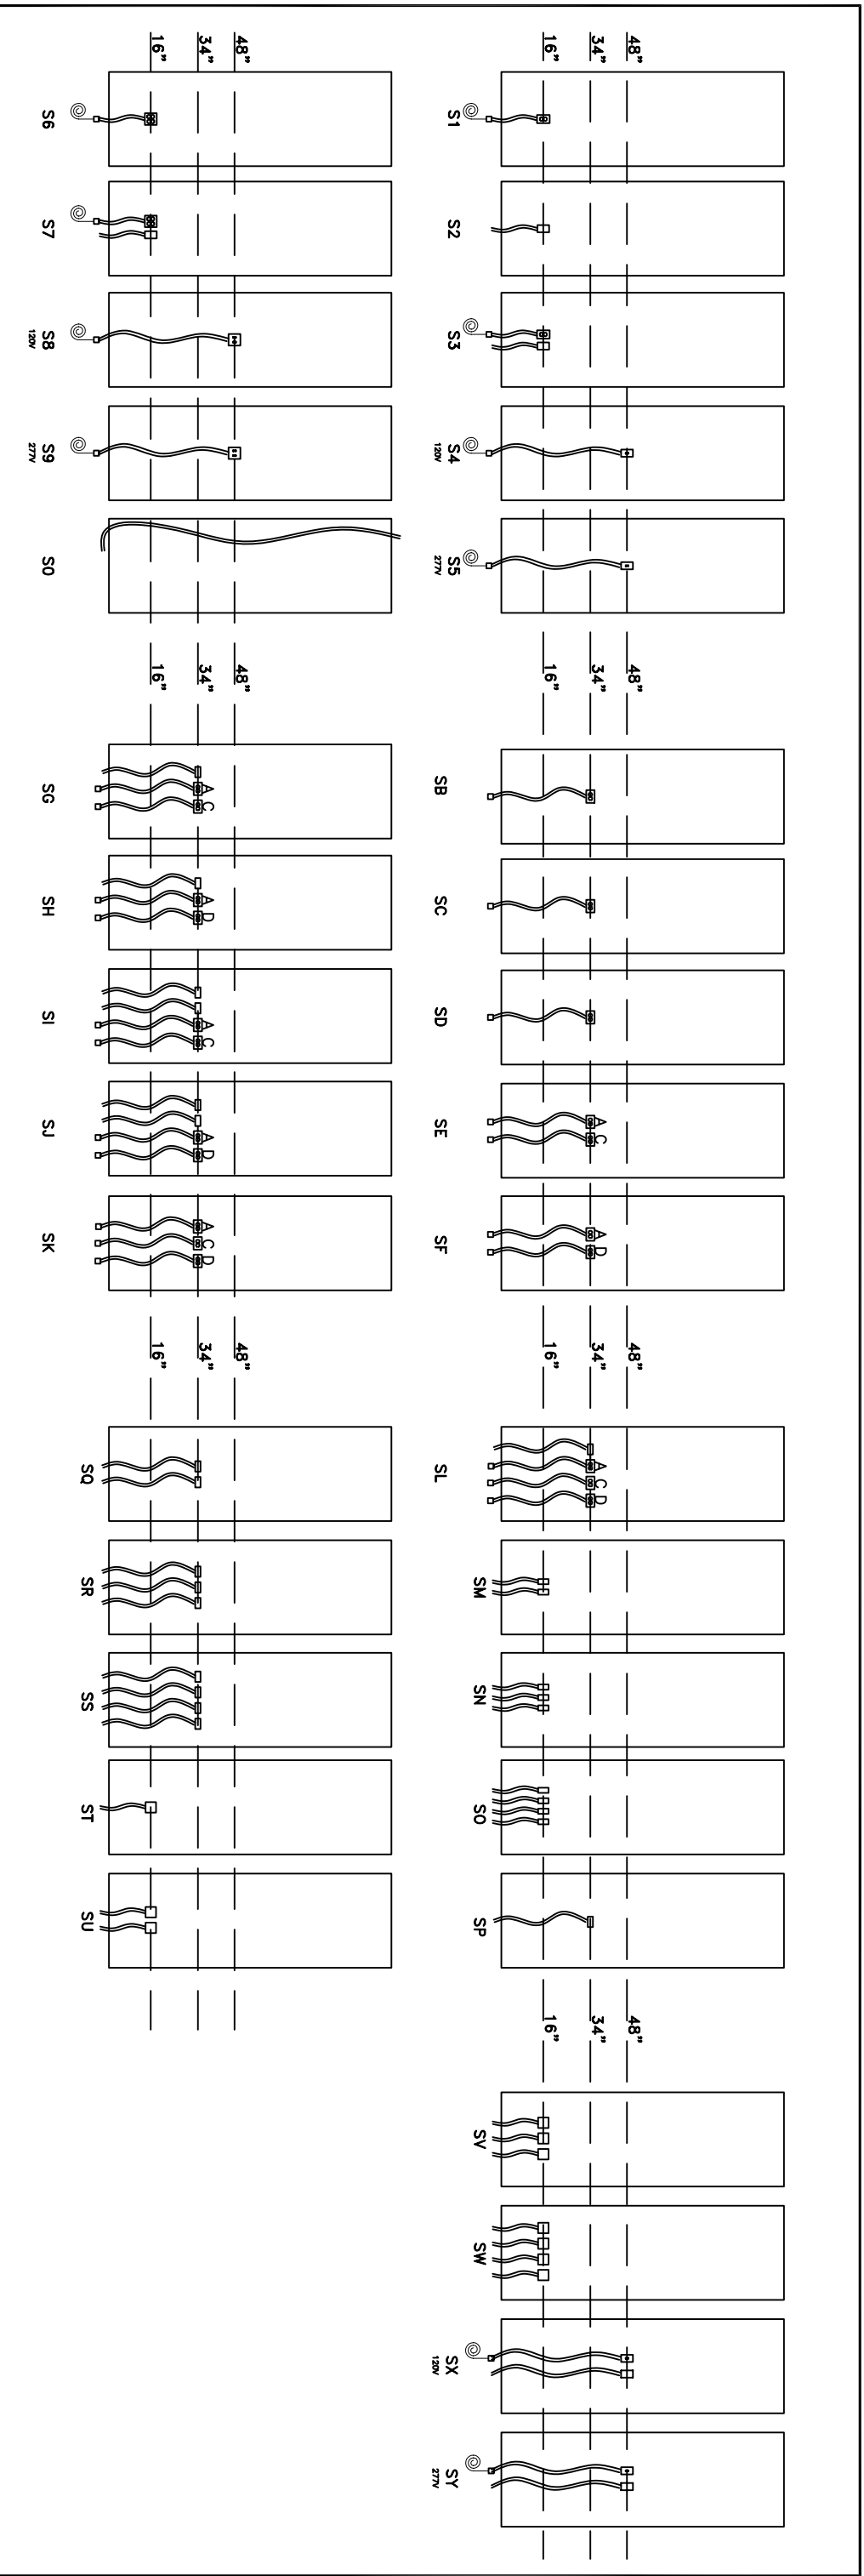

120V 277V

SCA Walls, Inc.
Herman Miller Wall Alliance

LEGEND: FINISHES

ALUM. FIN.	FRS FIN. #1	GLAZ. FIN. #1
BRZ. FIN. & HT	FRS FIN. #2	GLAZ. FIN. #2
DOOR	FRS FIN. #3	GLAZ. FIN. #3
OTHER	FRS FIN. #4	GLAZ. FIN. #4

This document contains Proprietary Information and is the sole property of SCA Walls, Inc. Any use thereof and/or reproduction is expressly prohibited without the prior written consent of SCA Walls, Inc.

DRAWN BY:	DATE:
CHECKED BY:	DATE:
AWARDED:	PHONE:
CUSTOMER SIGNATURE:	DATE:


www.scawalls.com

02

ELECTRICAL OPTIONS
S-OPTIONS

SCALE: 2 of 4
DRAWING NO.: SCA-Electrical Options

CANADIAN ELECTRICAL OPTIONS (ALL MEASUREMENTS A.F.F)

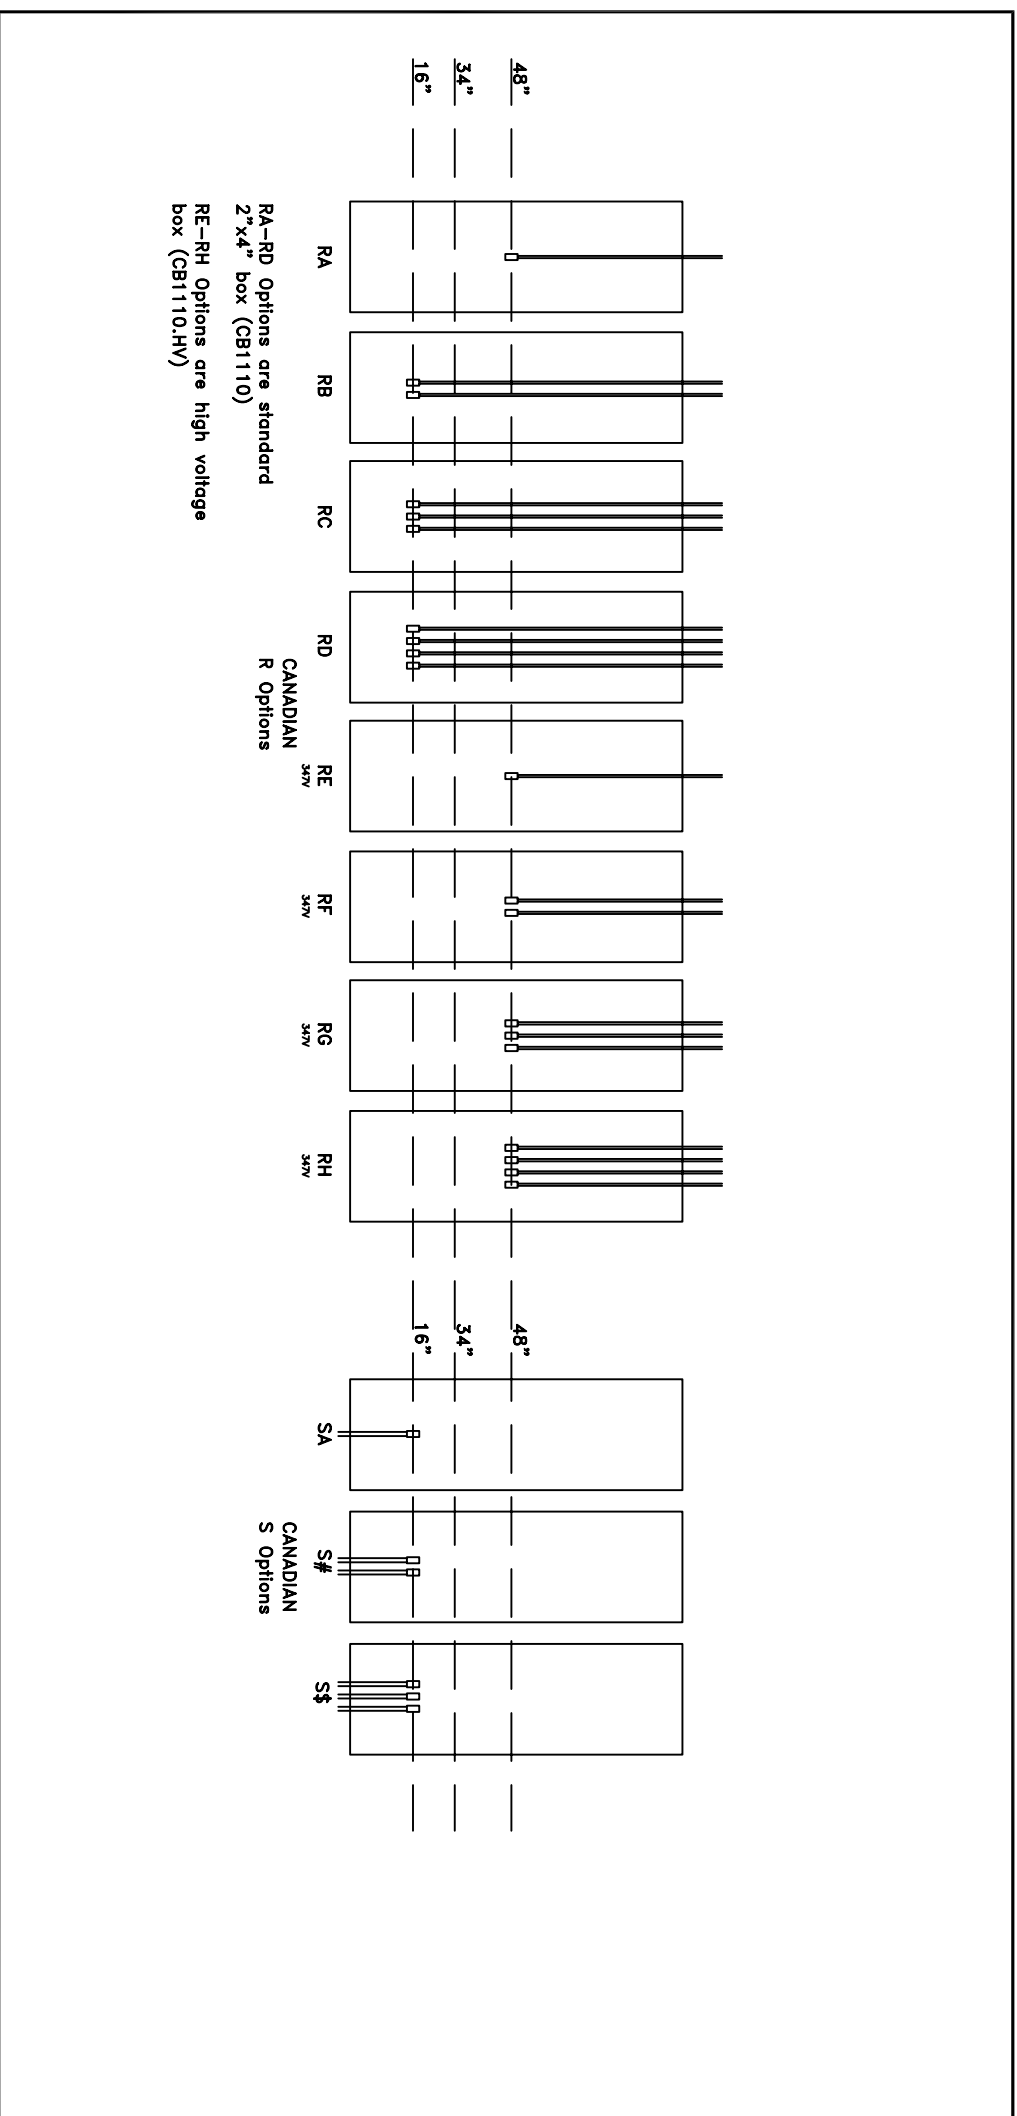

LEGEND: FINISHES

ALUM. FIN.	FIN. FIN. #1	GLAZ. FIN. #1
BASE FIN. & HT	FIN. FIN. #2	GLAZ. FIN. #2
DOOR	FIN. FIN. #3	GLAZ. FIN. #3
OTHER	FIN. FIN. #4	GLAZ. FIN. #4

This document contains Proprietary Information and is the sole property of SCA Walls, Inc. Any use thereof and/or reproduction is expressly prohibited without the prior written consent of SCA Walls, Inc.	
DRAWN BY: M. Lee	DATE: 10/24/07
CHECKED BY:	DATE:
AWARDED:	PHONE: 800.255.9255
CUSTOMER SIGNATURE:	DATE:

www.scawalls.com


ELECTRICAL OPTIONS

CANADIAN

SCALE: 3 of 4

DRAWING NO.: SCA-Electrical Options

ELECTRICAL LEGEND

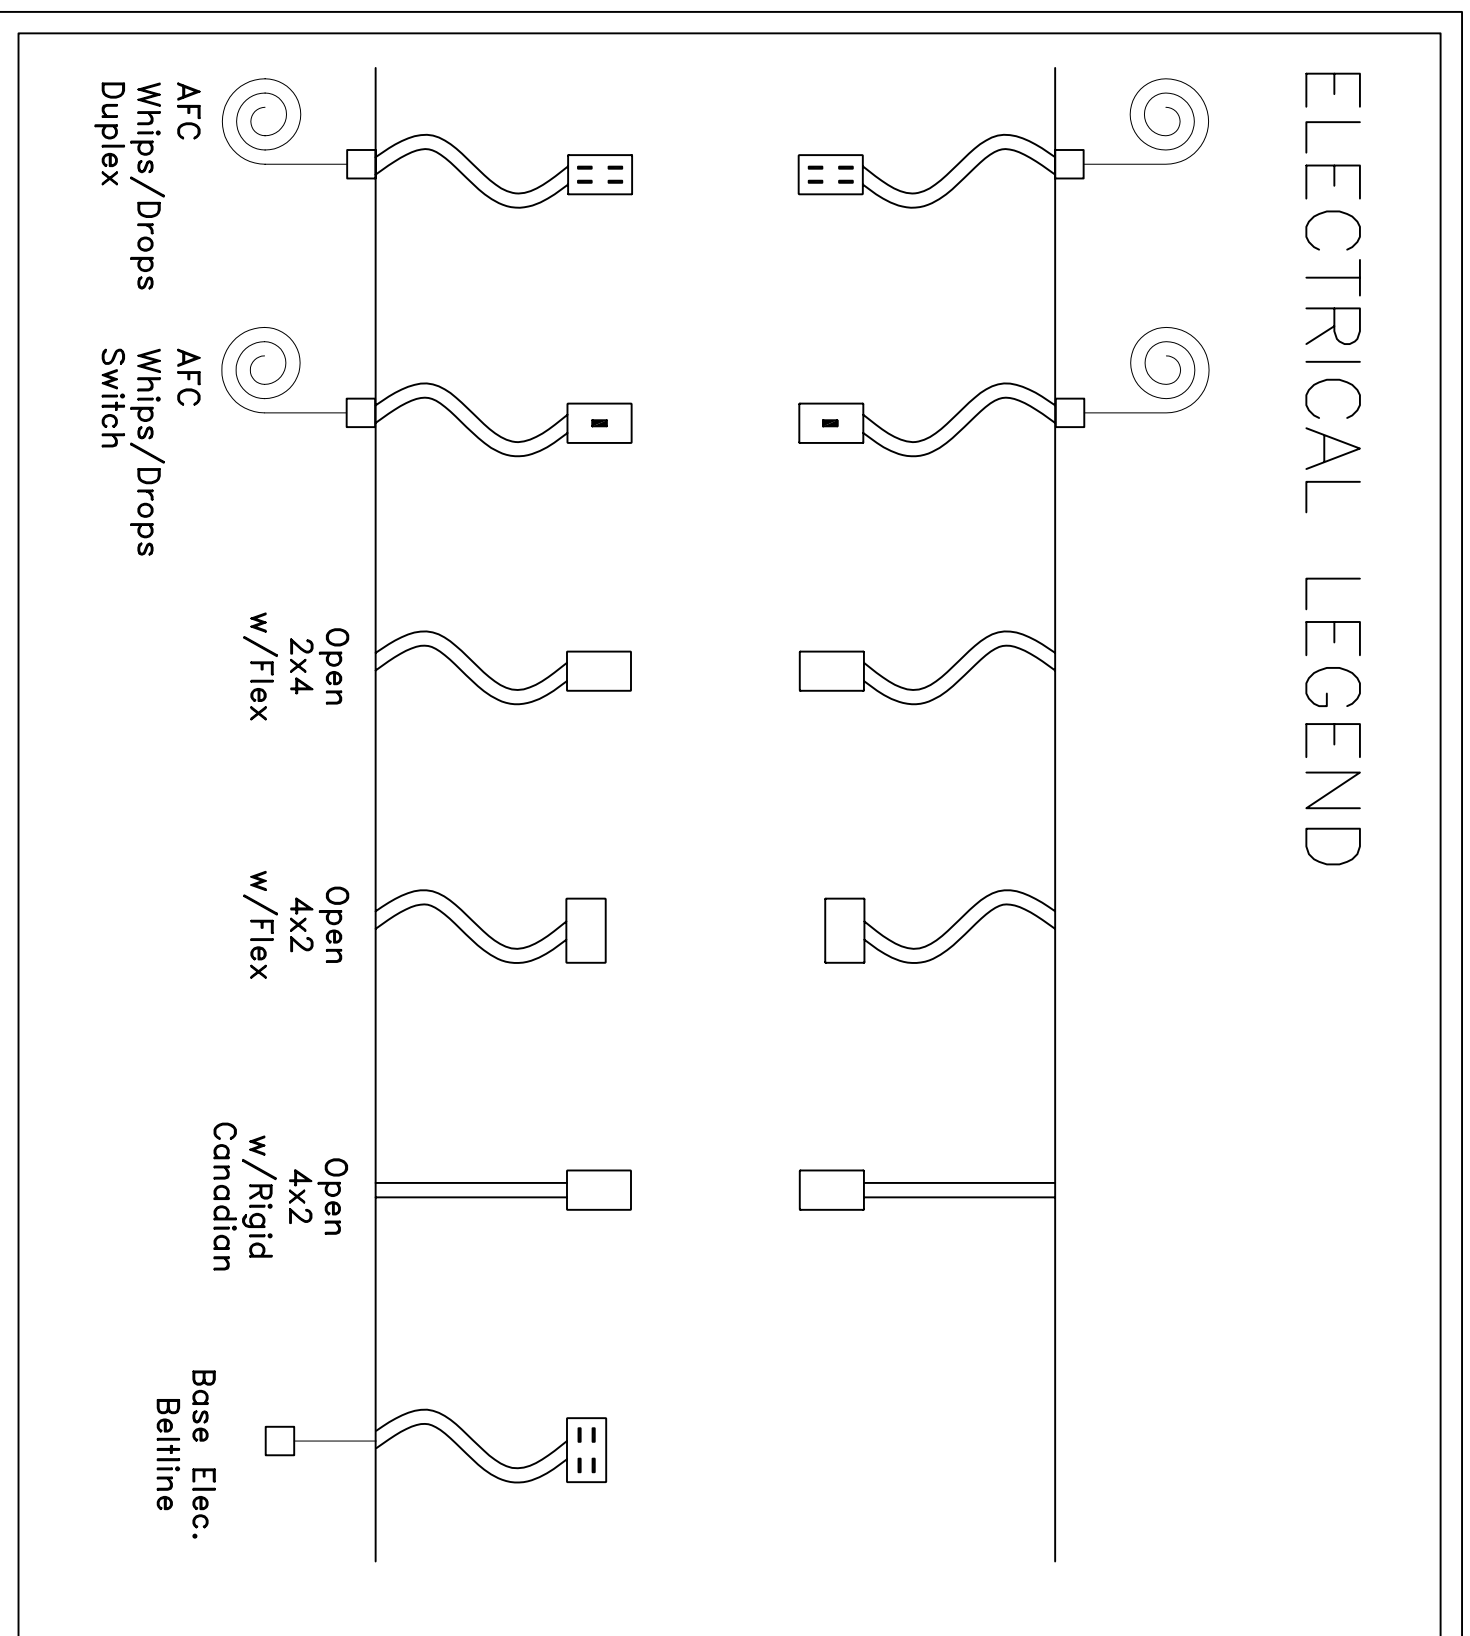

LEGEND: FINISHES

ALUM. FIN.	FRS FIN #1	GLAZ FIN #1
BASE FIN. & HT	FRS FIN. #2	GLAZ FIN. #2
DOOR	FRS FIN. #3	GLAZ FIN. #3
OTHER	FRS FIN. #4	GLAZ FIN. #4

This document contains Proprietary Information and is the sole property of SCA Walls, Inc. Any use thereof and/or reproduction is expressly prohibited without the prior written consent of SCA Walls, Inc.

DRAWN BY:	DATE:	8/31/07
CHECKED BY:	DATE:	
AWWAGER:	PHONE:	800.255.9255
CUSTOMER SIGNATURE:	DATE:	

04

www.scawalls.com	
ELECTRICAL OPTIONS	
LEGEND	
SCALE:	DRAWING NO.:
SHEET: 4 of 4	SCA-Electrical Options

SCA Walls, Inc.
Herman Miller Wall Alliance